

- (S) HARDWIRED AND INTERCONNECTED SMOKE ALARM
- (CM) HARDWIRED AND INTERCONNECTED CARBON MONOXIDE ALARM - UL 2034


# ↖ z

**FIRST FLOOR PLAN**

SCALE: 3/16" = 1'-0"

PROFESSIONAL CERTIFICATION: I, ARNOLD CERRITO, HAVE THESE DOCUMENTS PREPARED OR PREPARED UNDER MY CLOSE PERSONAL SUPERVISION AND I AM A REGISTERED PROFESSIONAL ARCHITECT IN THE STATE OF MARYLAND, LICENSE NO. 23091 EXPIRATION DATE 04/14/2021

1100 W LAFAYETTE AVE BALTIMORE MD, 21217		A1
RENOVATION		
<b>ARENCO, LLC</b>		
ARCHITECTURE ENGINEERING CONSULTANTS		
8207 BRADDOCK LANE COURT		
LAUREL, MARYLAND 20723		
SHEET	DRAWING NO.	
WORK REQUEST #	01 OF 03	20-226-01
AS SHOWN	20-226	20-226-01

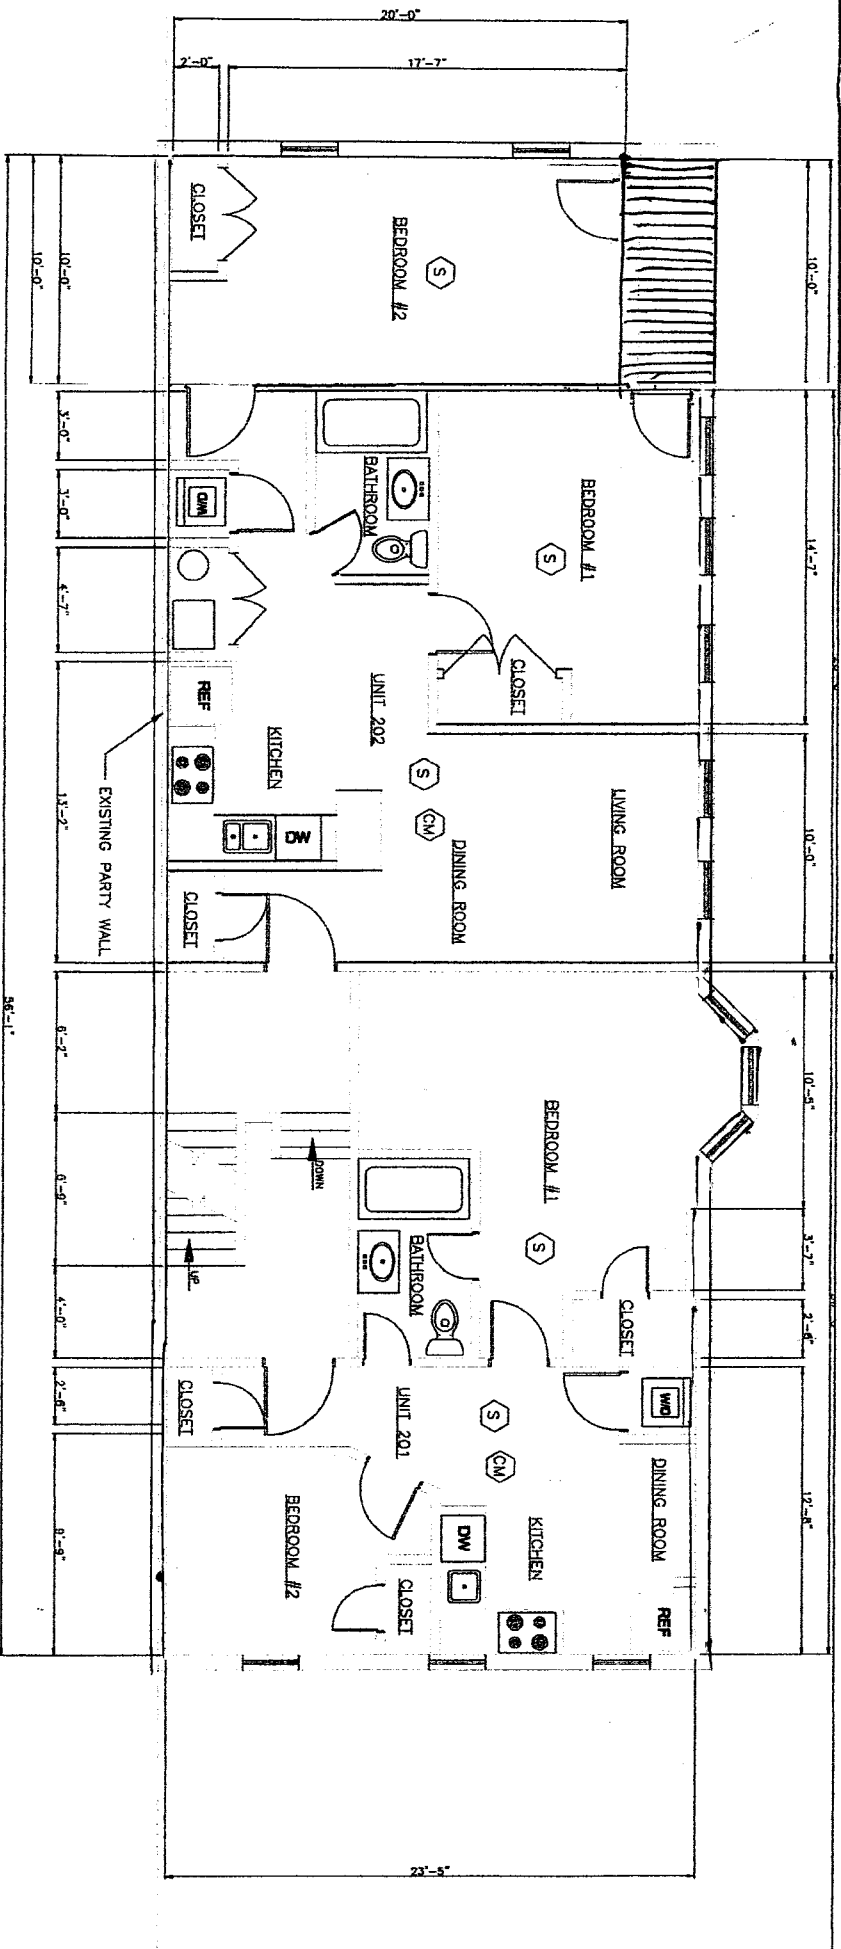

- (S) HARDWIRED AND INTERCONNECTED SMOKE ALARM
- (CM) HARDWIRED AND INTERCONNECTED CARBON MONOXIDE ALARM -UL 2034

SECOND FLOOR PLAN  
 SCALE: 3/16" = 1'-0"

PROFESSIONAL CERTIFICATION: I HEREBY CERTIFY THAT THESE DOCUMENTS WERE PREPARED OR APPROVED BY ME, AND THAT I AM A DULY LICENSED PROFESSIONAL ENGINEER UNDER THE LAWS OF THE STATE OF MARYLAND, LICENSE NO. 23081 EXPIRATION DATE: 04/24/2021

**1100 W LAFAYETTE AVE**  
**BALTIMORE MD, 21217**

**ARENCO, LLC**  
 ARCHITECTURAL ENGINEERING CONSULTANTS  
 6207 DRAMONDTLY COURT  
 LARABEL, MARYLAND 20725

**SECOND FLOOR PLAN**  
**RENOVATION**


**A2**

SCALE AS SHOWN

WORK SHEET 20-128 02 OF 03 20-128-02

- Ⓢ HARDWIRED AND INTERCONNECTED SMOKE ALARM
- Ⓤ HARDWIRED AND INTERCONNECTED CARBON MONOXIDE ALARM - UL 2034

THIRD FLOOR PLAN  
 SCALE: 3/16" = 1'-0"

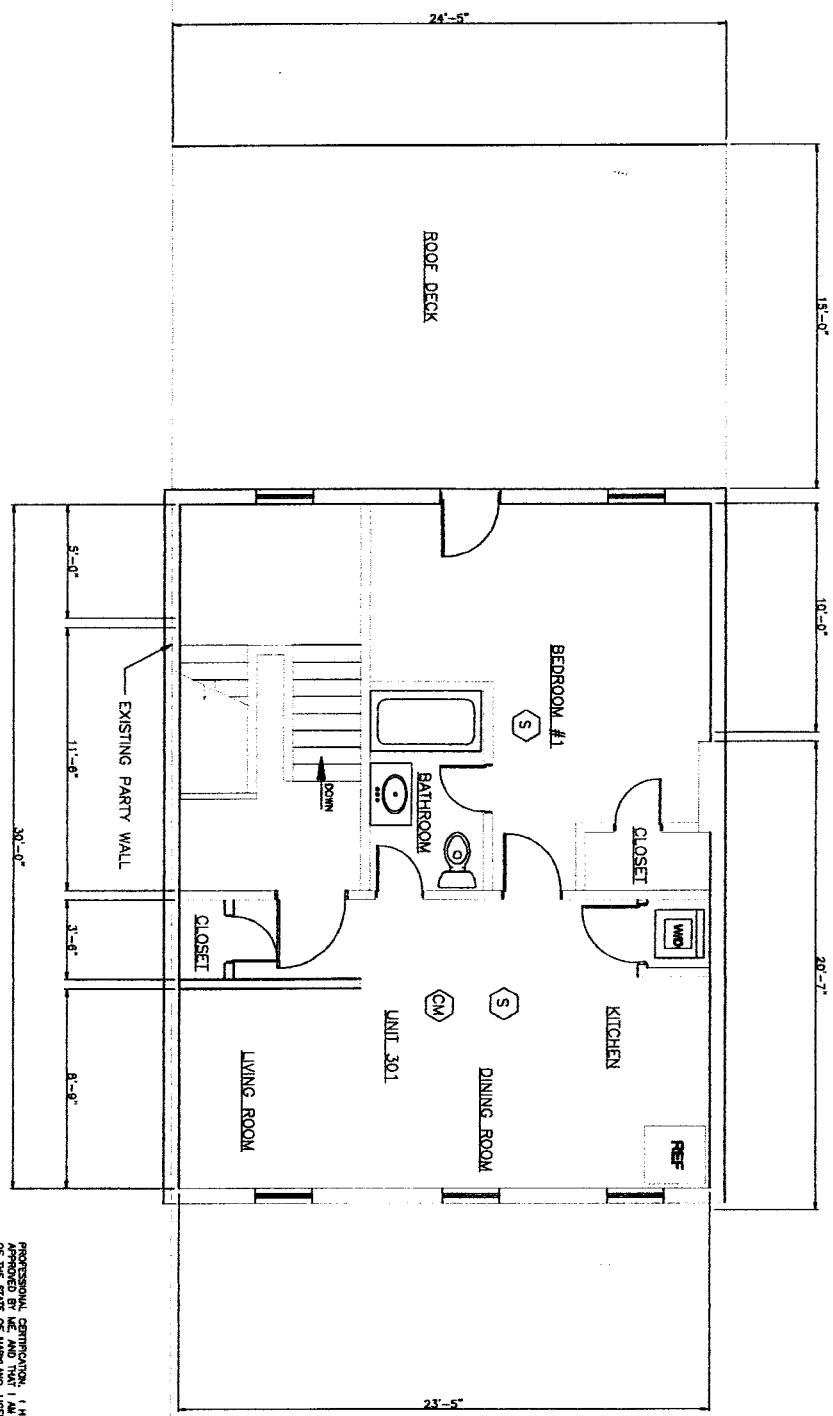

PROFESSIONAL CERTIFICATE: I, JERRY GREGG, HAVE REVIEWED THESE DOCUMENTS AND APPROVED BY ME AND THAT I AM A FULLY LICENSED PROFESSIONAL ENGINEER UNDER THE LAWS OF THE STATE OF MARYLAND, LICENSE NO. 23081 EXPIRATION DATE: 04/24/2021

1100 W LAFAYETTE AVE		A3
BALTIMORE MD, 21217		
RENOVATION		
THIRD FLOOR PLAN		
ARENCO, LLC		
ARCHITECTURAL ENGINEERING CONSULTANTS		
8207 DRAGONFLY COURT		
LARBEL, MARYLAND 20723		
SCALE AS SHOWN	WORK REQUEST #	DRAWING NO.
	20-226	20-226-03
	03 OF 03	